


1
SET-OUT

B06 - SPORT ACTIVITIES - SETTING-OUT PLANE


SCALE 1:75 M

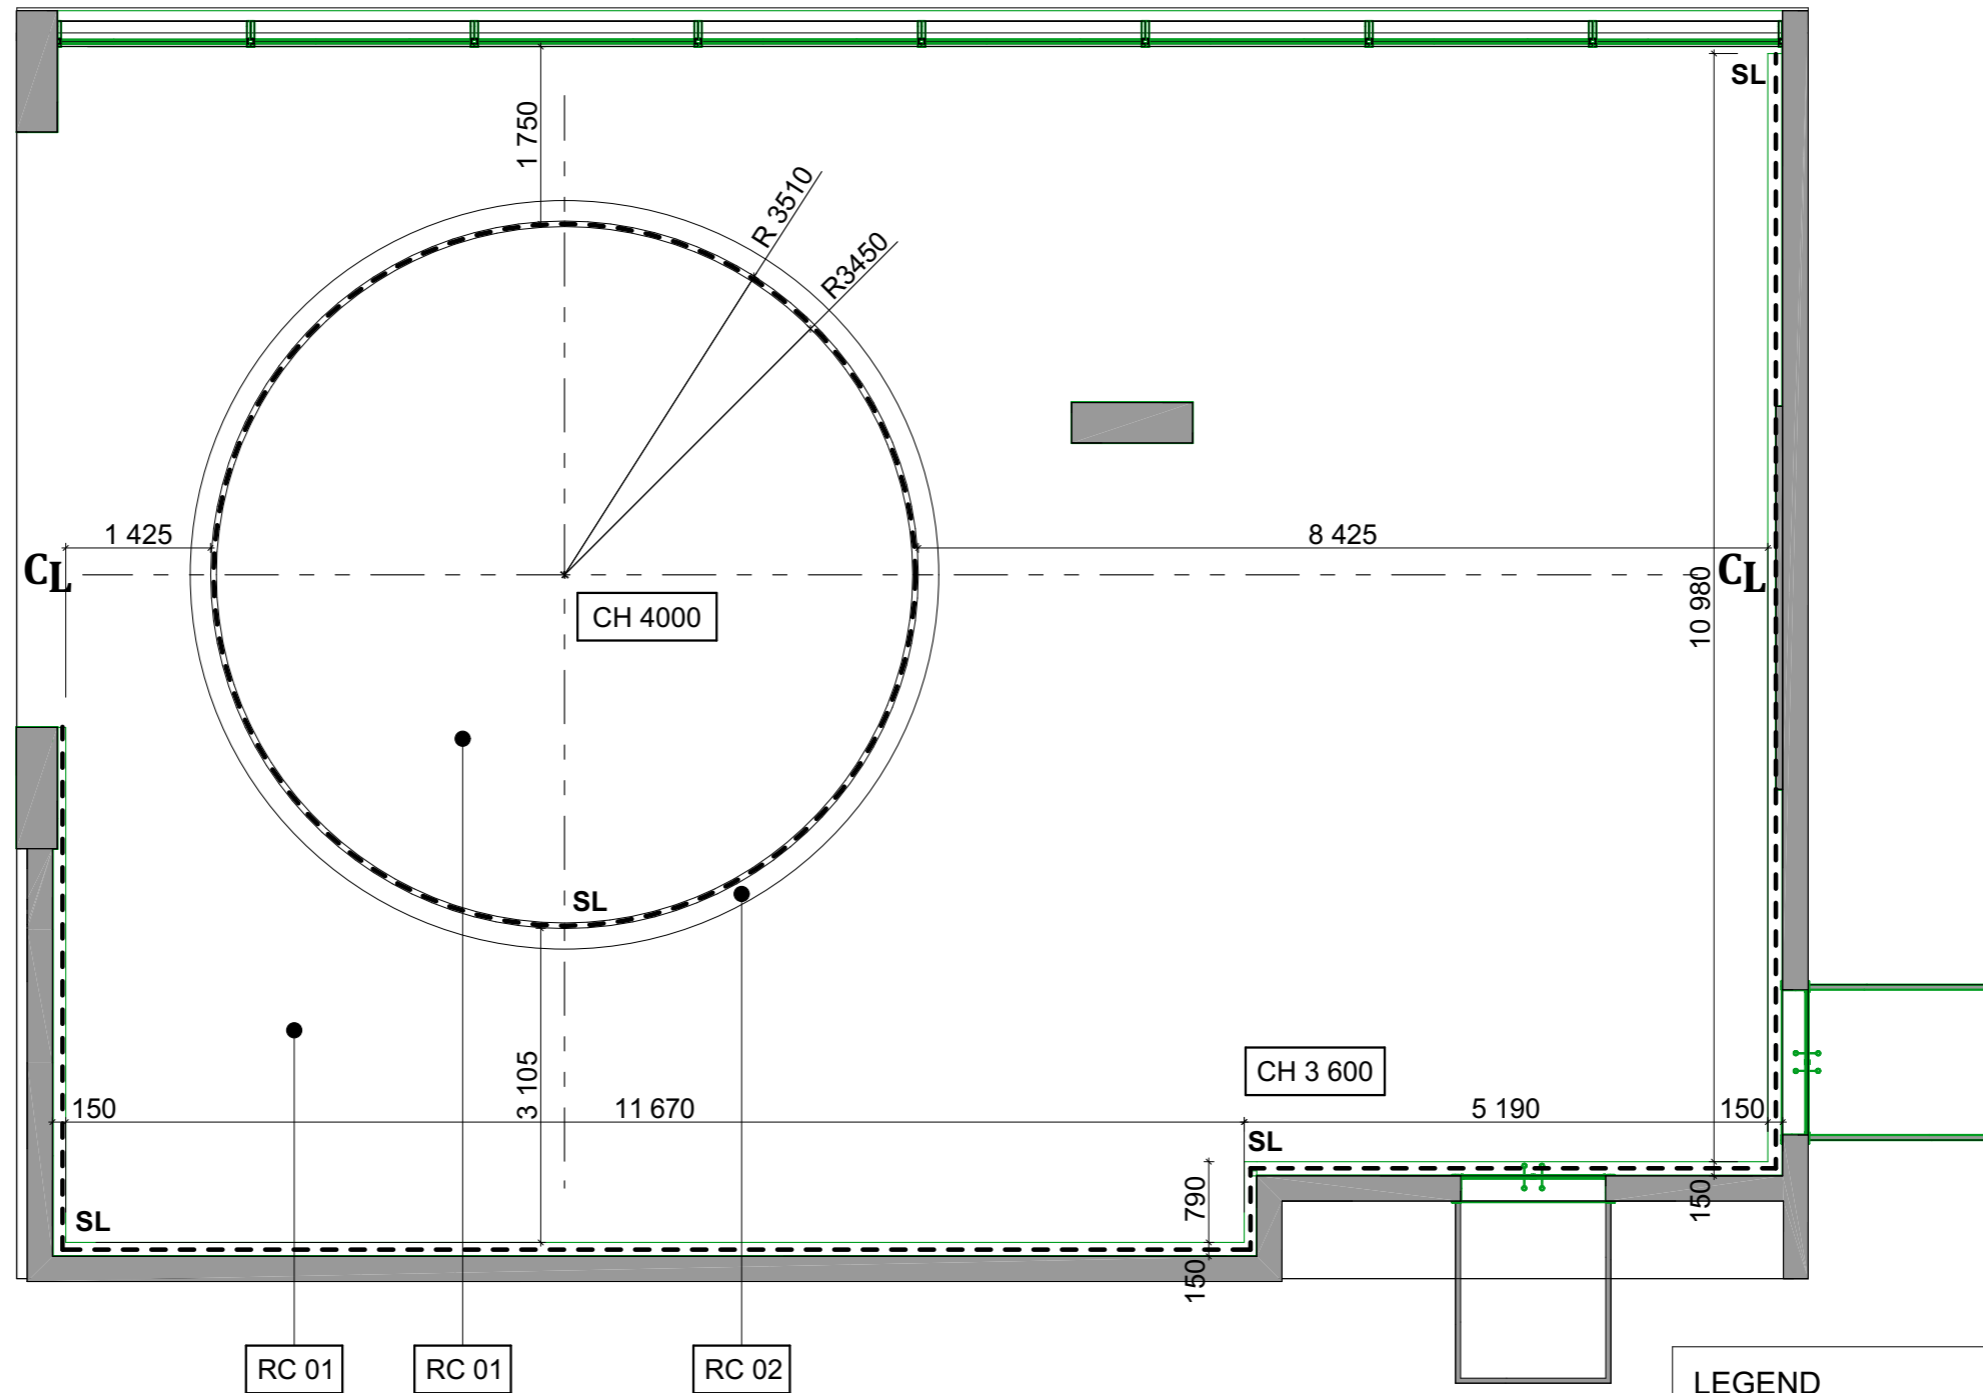

2 B06 - SPORT ACTIVITIES - REFLECTED CEILING PLAN
 CEILING SCALE 1:75 M

LEGEND	
	RECESSED STRIP LIGHT
	SMOKE DETECTOR
	PIR MOTION SENSORPIR
	CEILING HEIGHT
	REFLECTED CEILING

FOR THE LOCATIONS OF ALL OF ABOVE, PLEASE REFER TO LIGHTING CONSULTANT DRAWINGS.

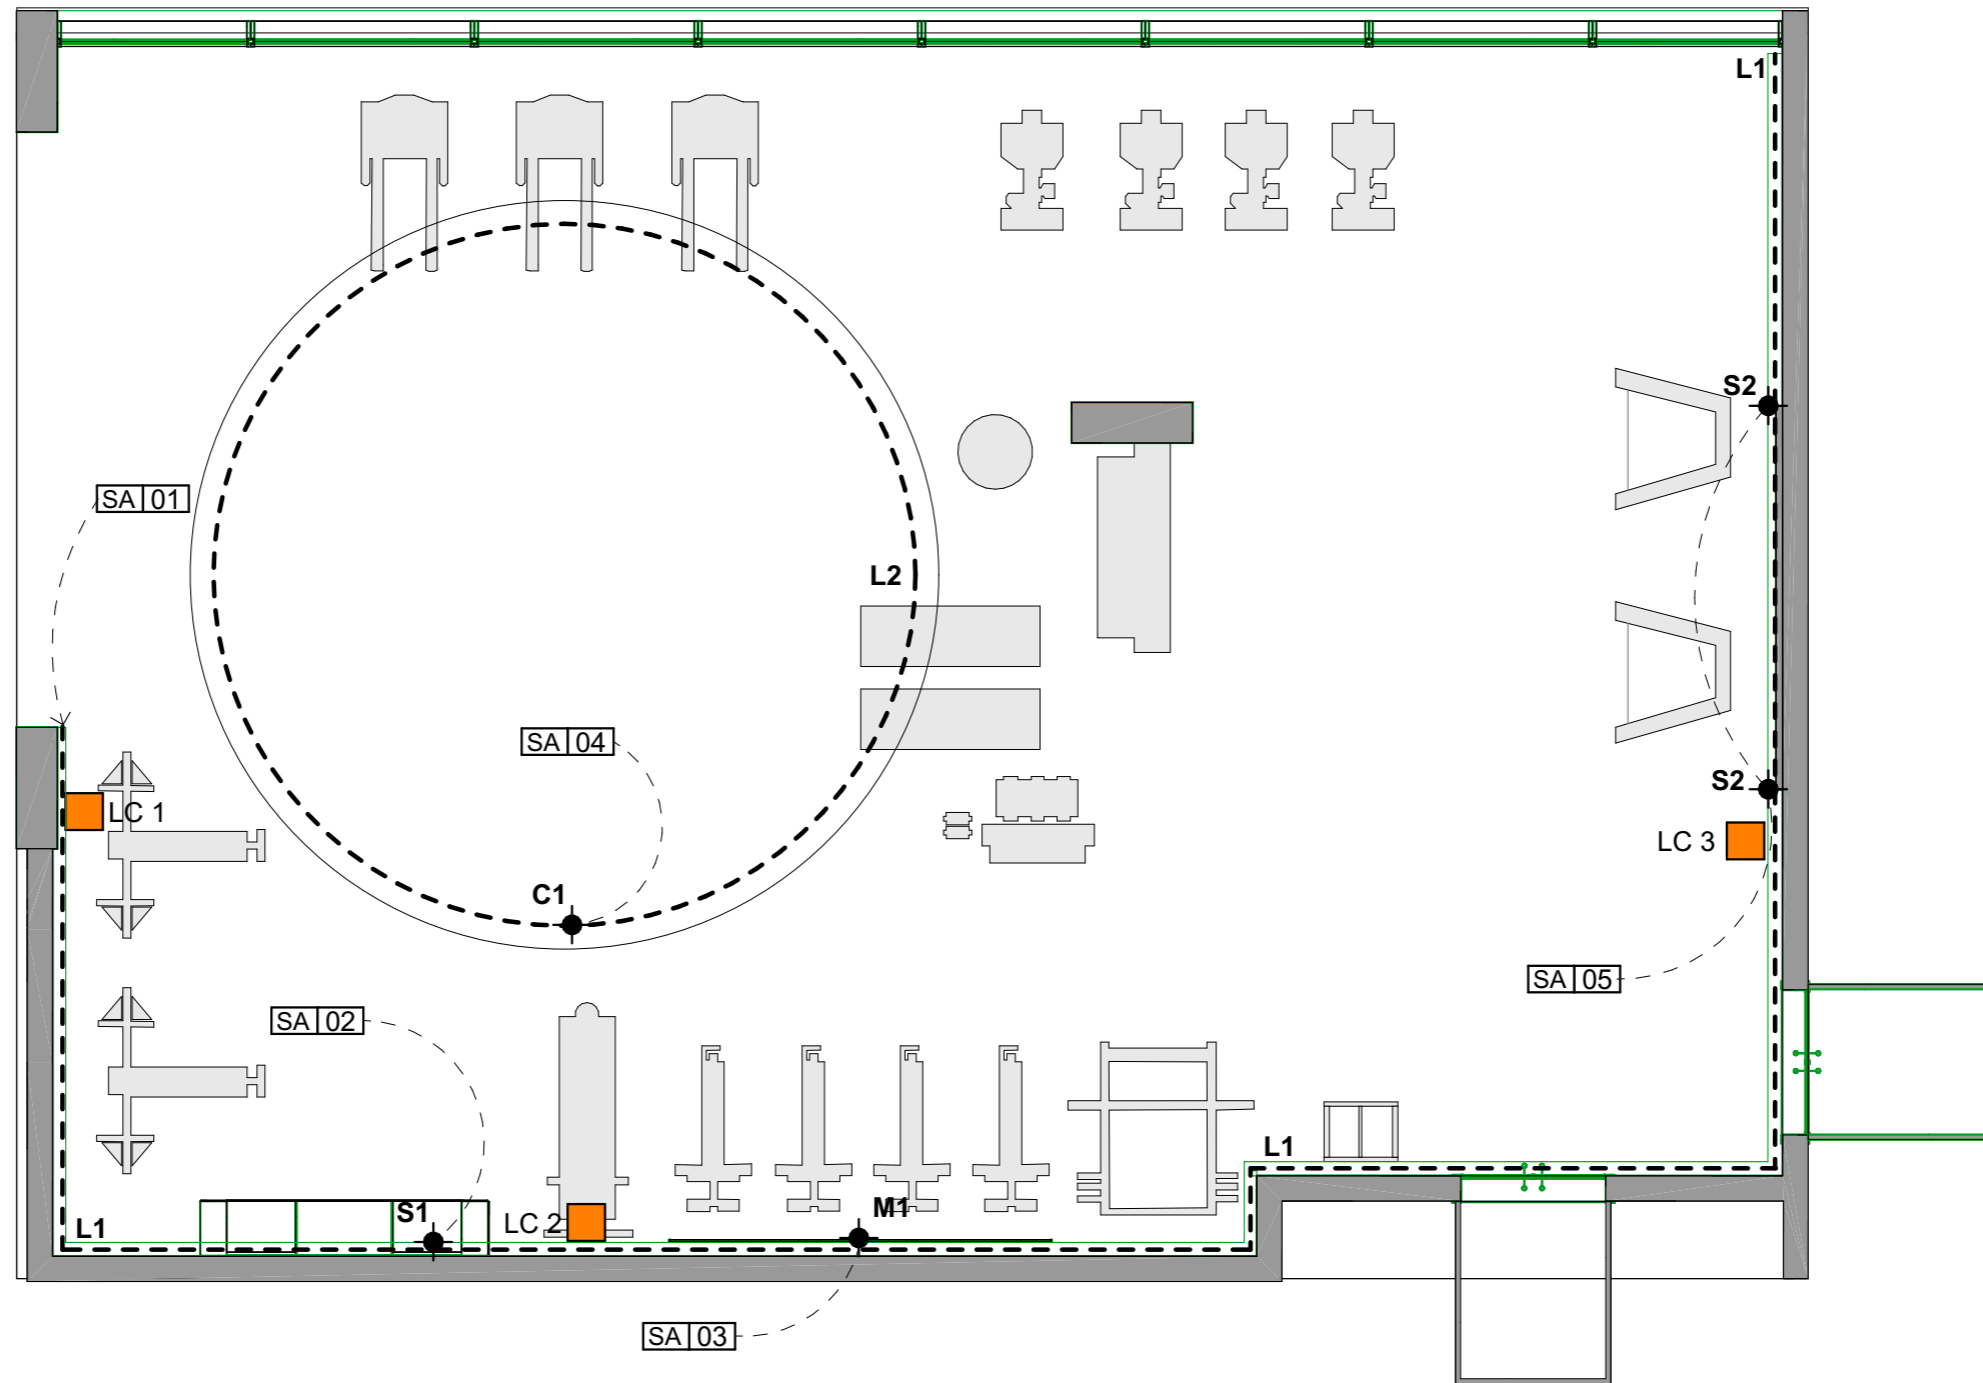

3 B06 - SPORT ACTIVITIES - LIGHTING & CONTROL PLAN
 LIGHTING SCALE 1:75 M

LIGHTING CONTROL SEQUENCE
 (ONLY LIGHTING SPECIFIC CONTROL SHOW)


LC1 (ENTRANCE PANEL)	LC2 (WALL PANEL)	LC3 (SPORT ACTIVITIES AREA)
<input type="checkbox"/> MASTER <input type="checkbox"/> DIM +/- <input type="checkbox"/> DIM -/	<input type="checkbox"/> MIRROR LIGHT <input type="checkbox"/> SHELVES LIGHT	<input type="checkbox"/> MASTER <input type="checkbox"/> SIDE LIGHTING

LIGHTING & CONTROL LEGEND


SYMBOL	REF	DESCRIPTION
---	L1	LINEAR LED
---	L2	LINEAR LED
●	C1	CEILING HEIGHT
●	S1	SHELVES LIGHT
●	M1	MIRROR LIGHT
●	S2	SIDE LIGHT

LIGHTING SEQUENCE LEGEND


SPORT ACTIVITIES AREA SA XX LIGHTING SEQUENCES NUMBE

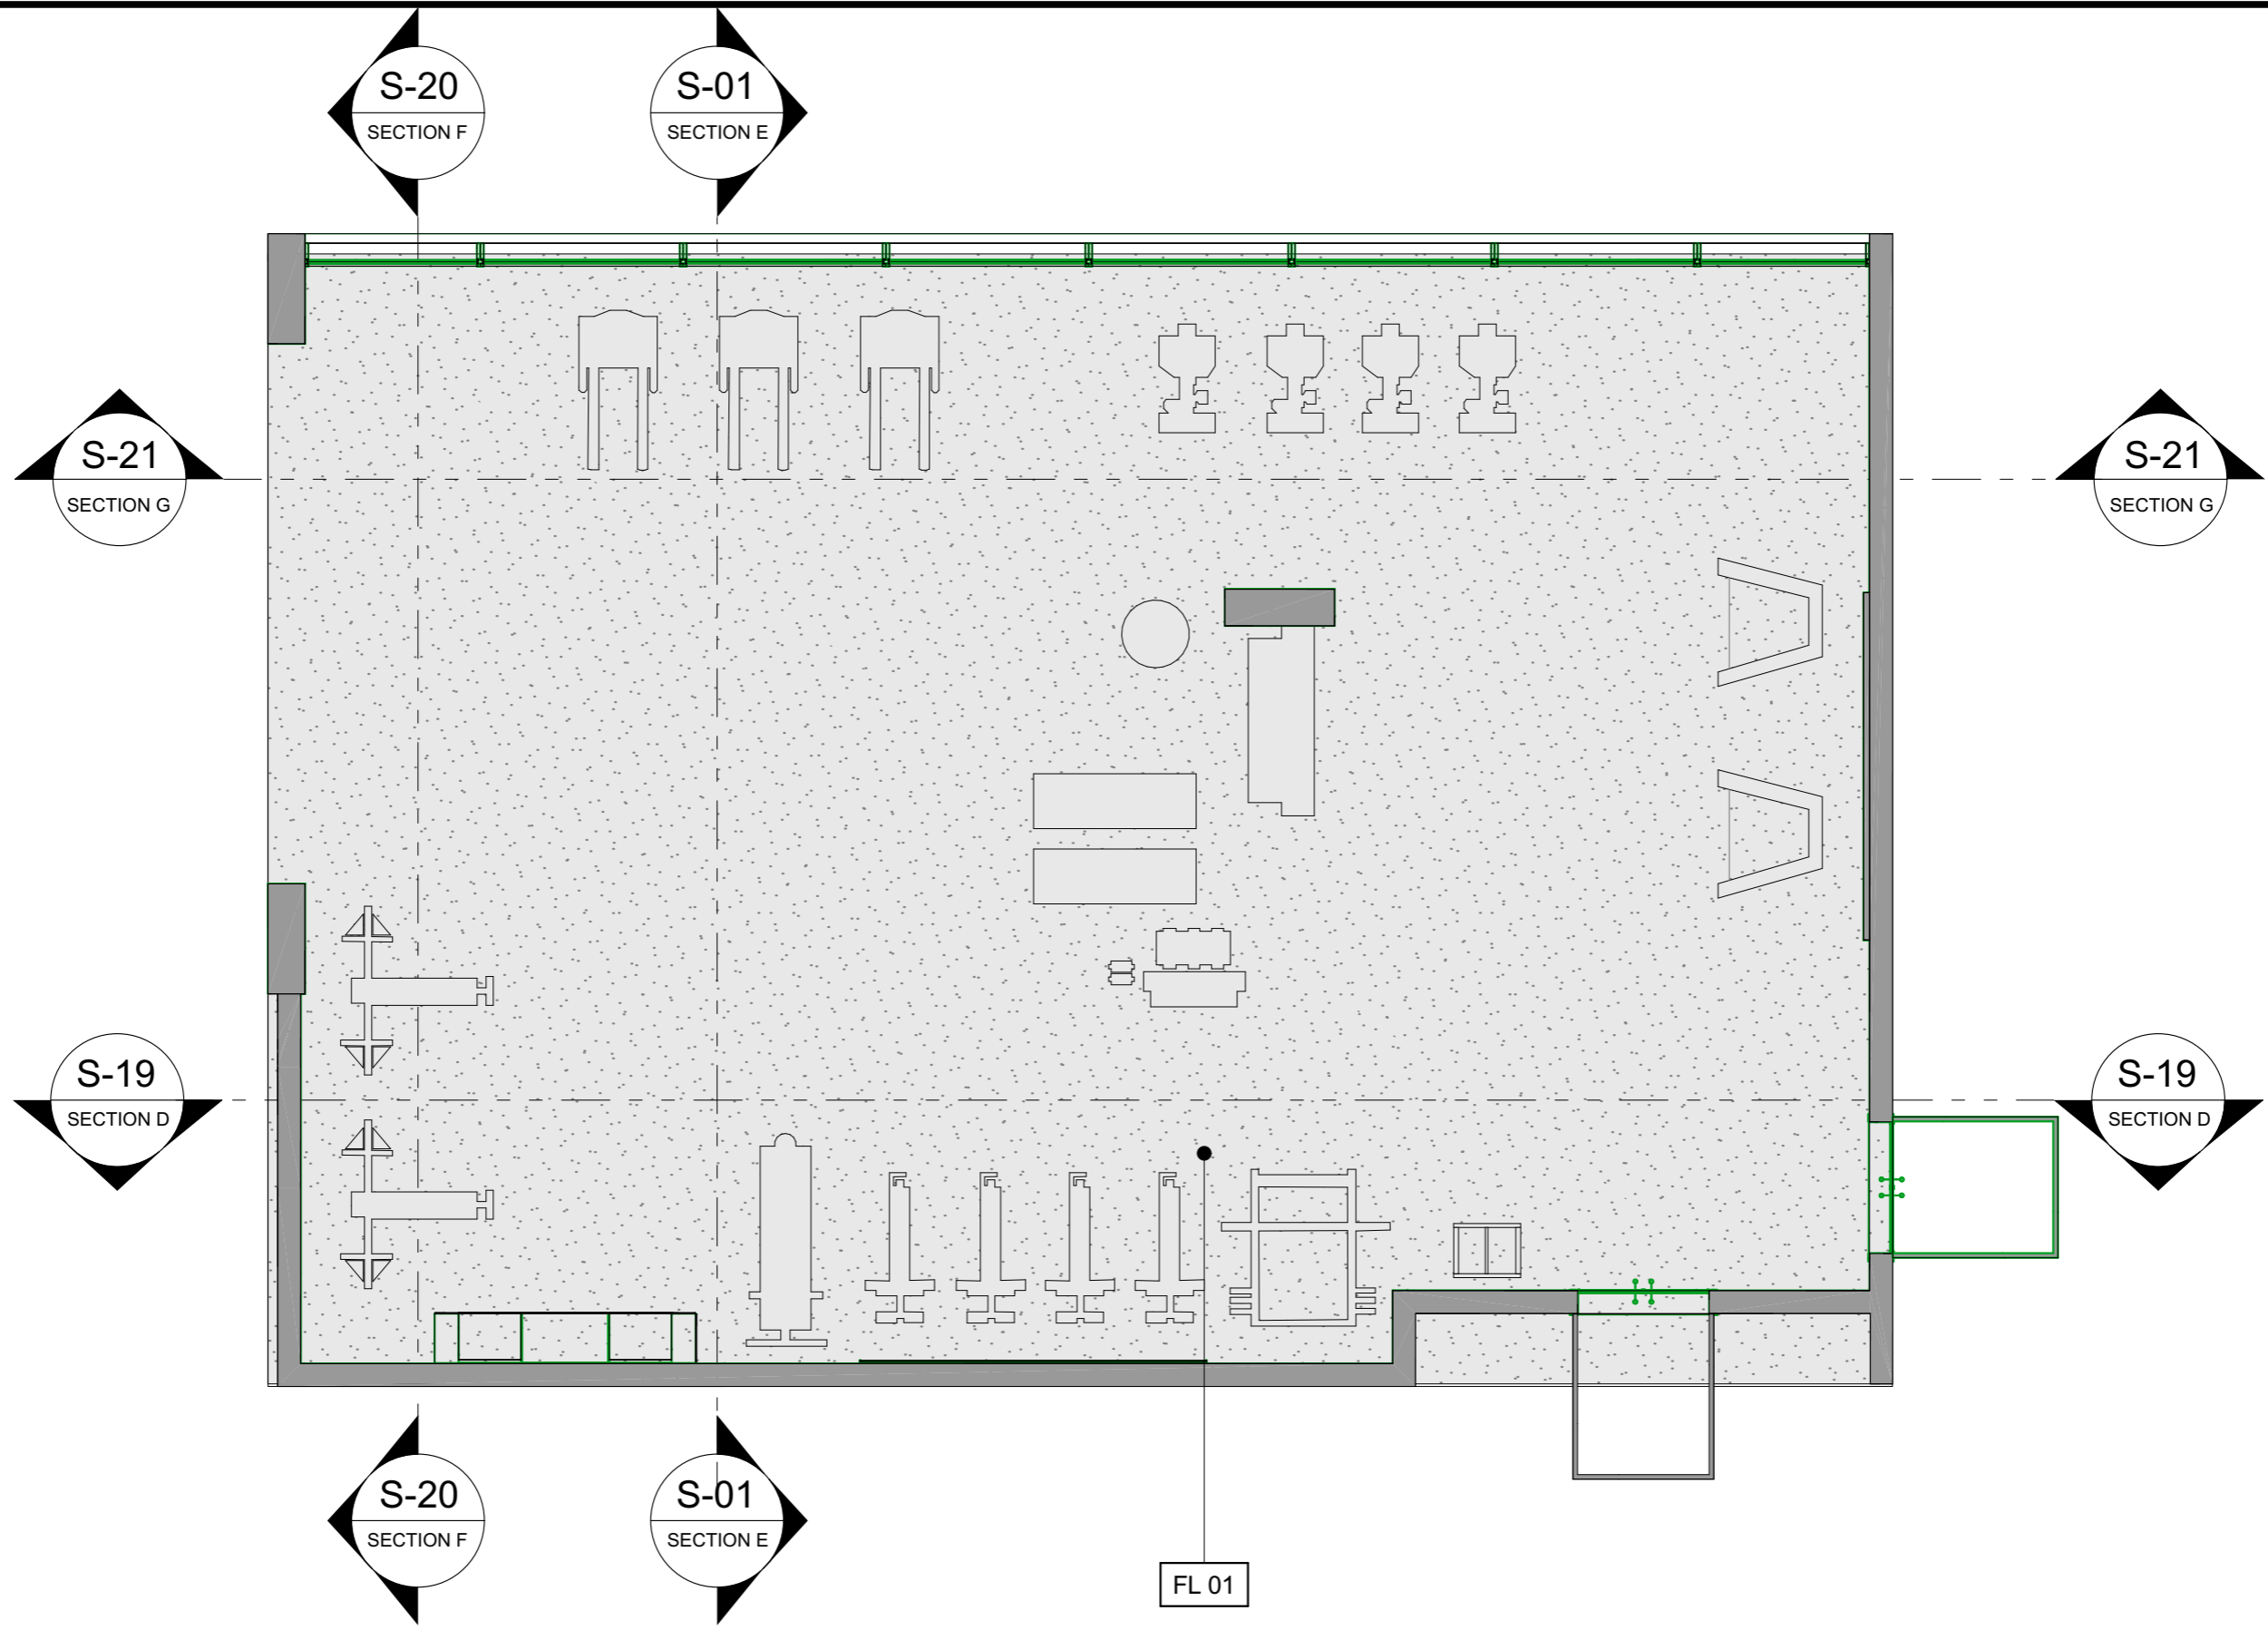

4
B06 - SPORT ACTIVITIES - FLOORING PLANE
FLOORING SCALE 1:75 M

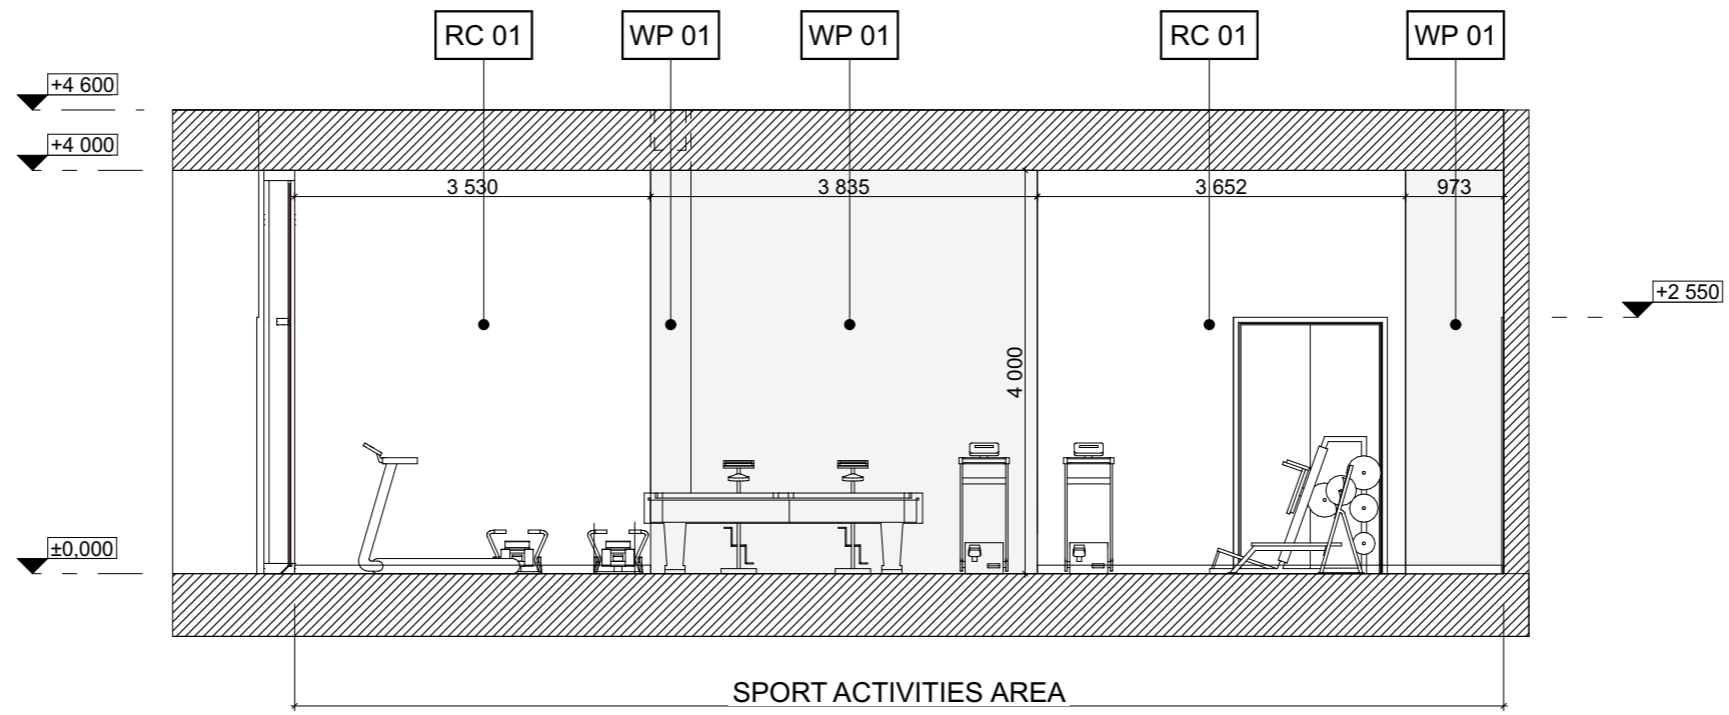

S1 - SECTION E

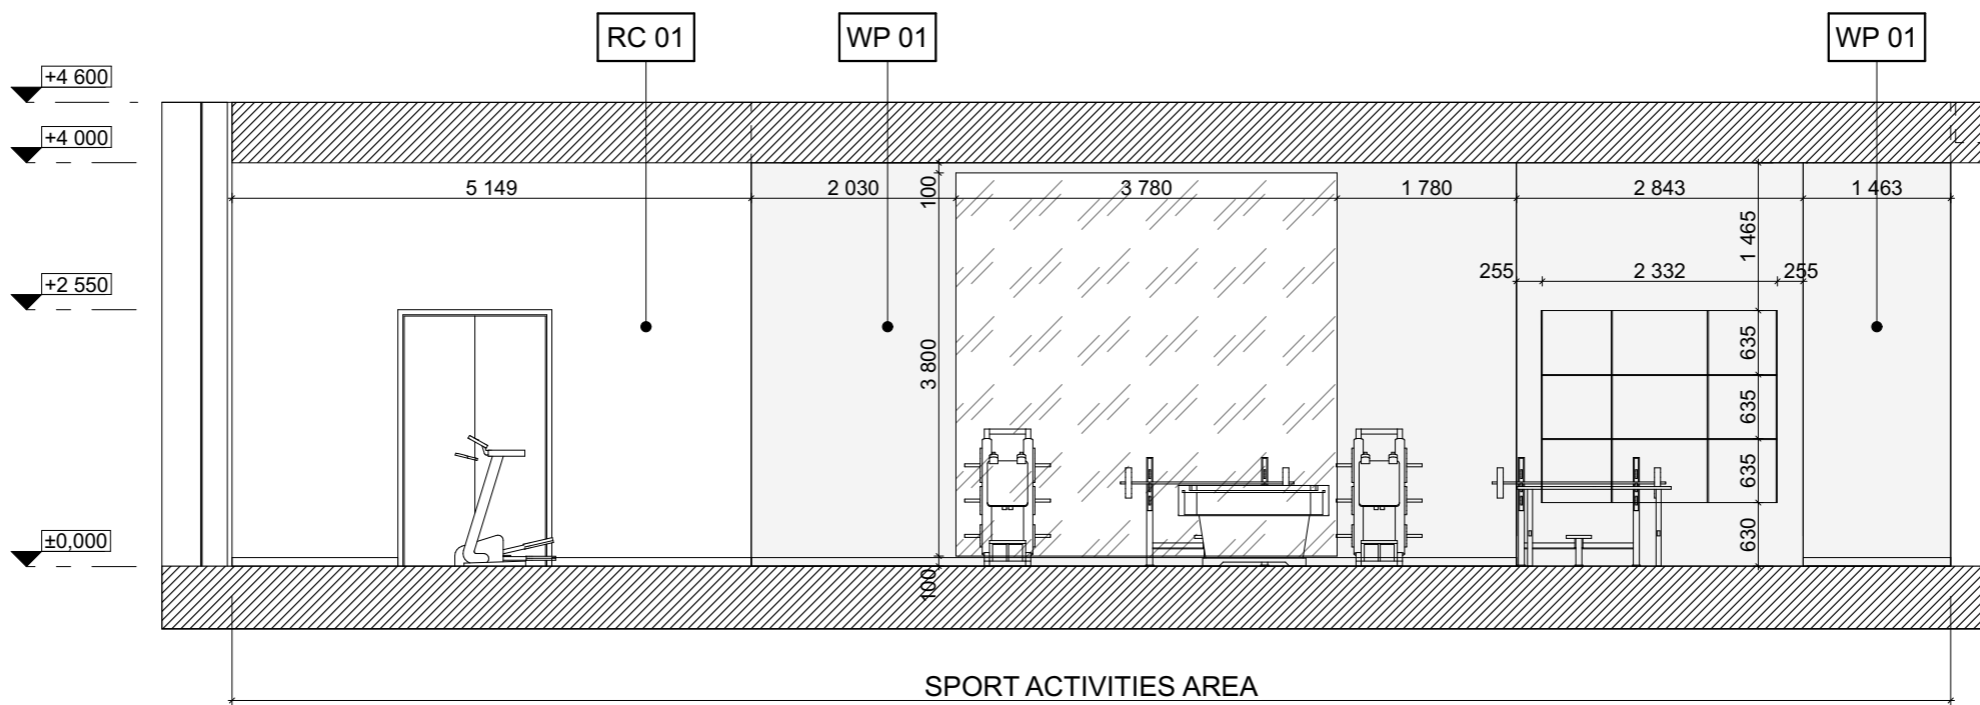


S19 SECTION


5
WALLS
SECTION

B06 - SPORT ACTIVITIES - WALLS SECTION

SCALE 1:75 M

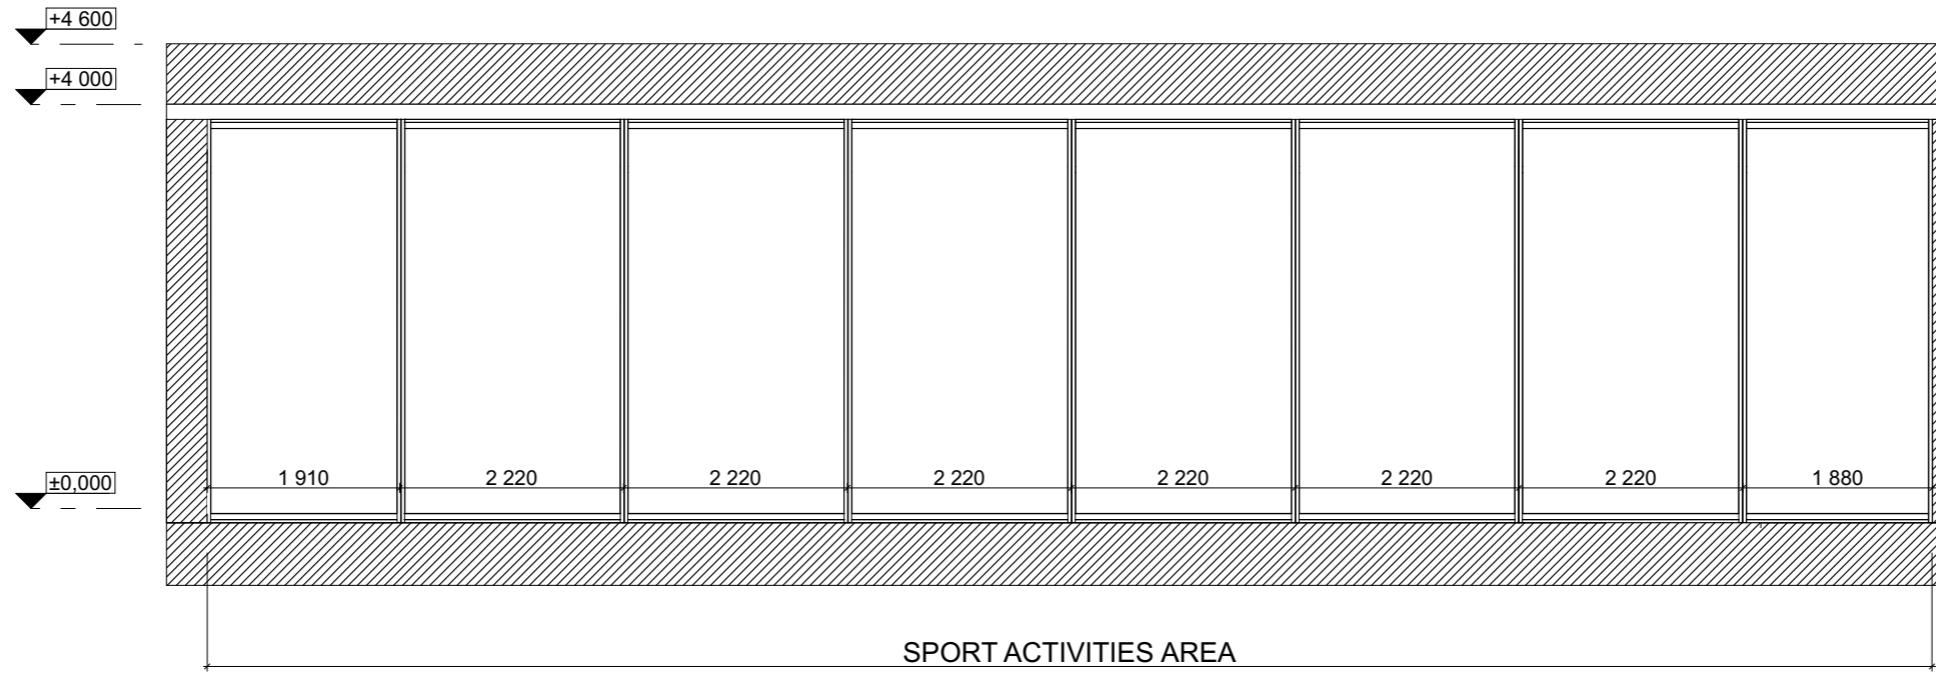

S21 SECTION

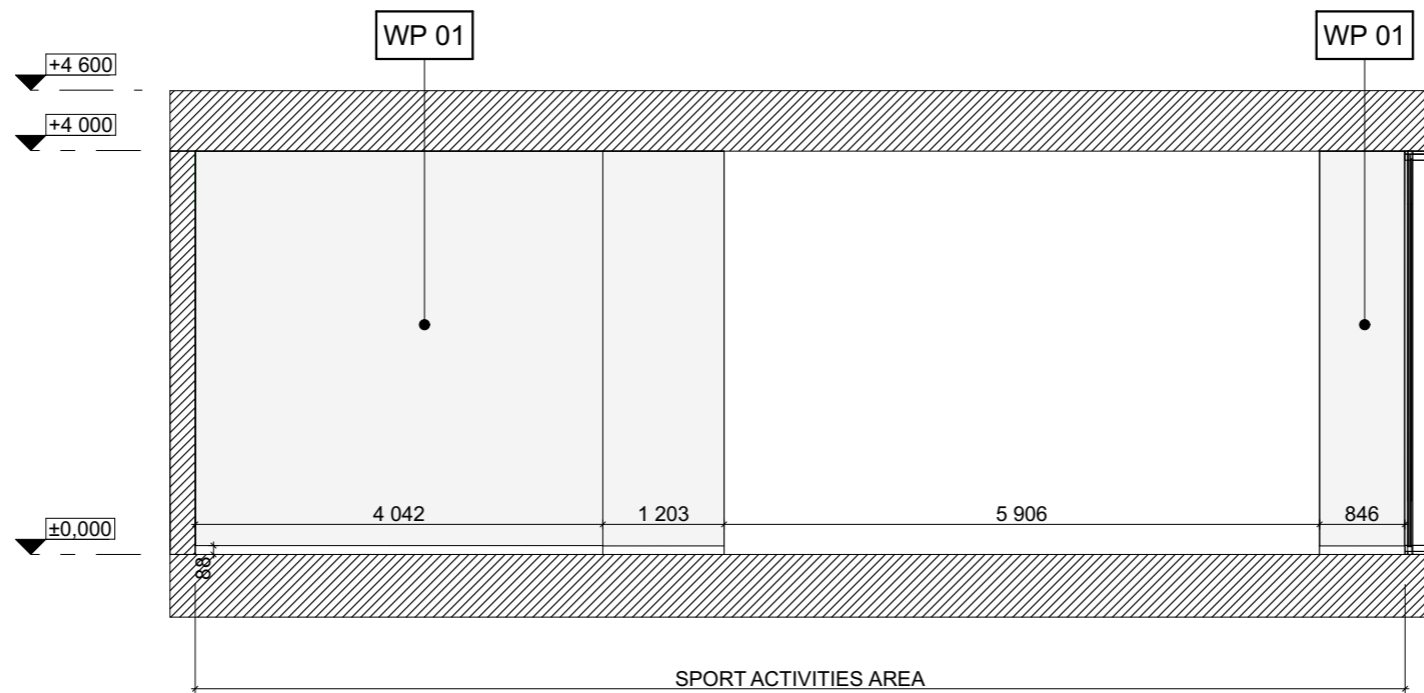

S22 SECTION

6
WALLS
SECTION

B06 - SPORT ACTIVITIES - WALLS SECTION

SCALE 1:75 M